


BONNINESS

부산대학교
실내환경디자인학과
김민영 김재영

CONTENTS

DRAWING NO.	DRAWING TITLE	SCALE
01	1st FLOOR PLAN	1/250
02	2nd FLOOR PLAN	1/200
03	3rd FLOOR PLAN	1/200
04	1st ELEVATION 2nd ELEVATION	1/200
05	1st CEILING PLAN	1/250
06	2nd CEILING PLAN	1/200
07	3rd CEILING PLAN	1/200
	LIGHTS	1/150

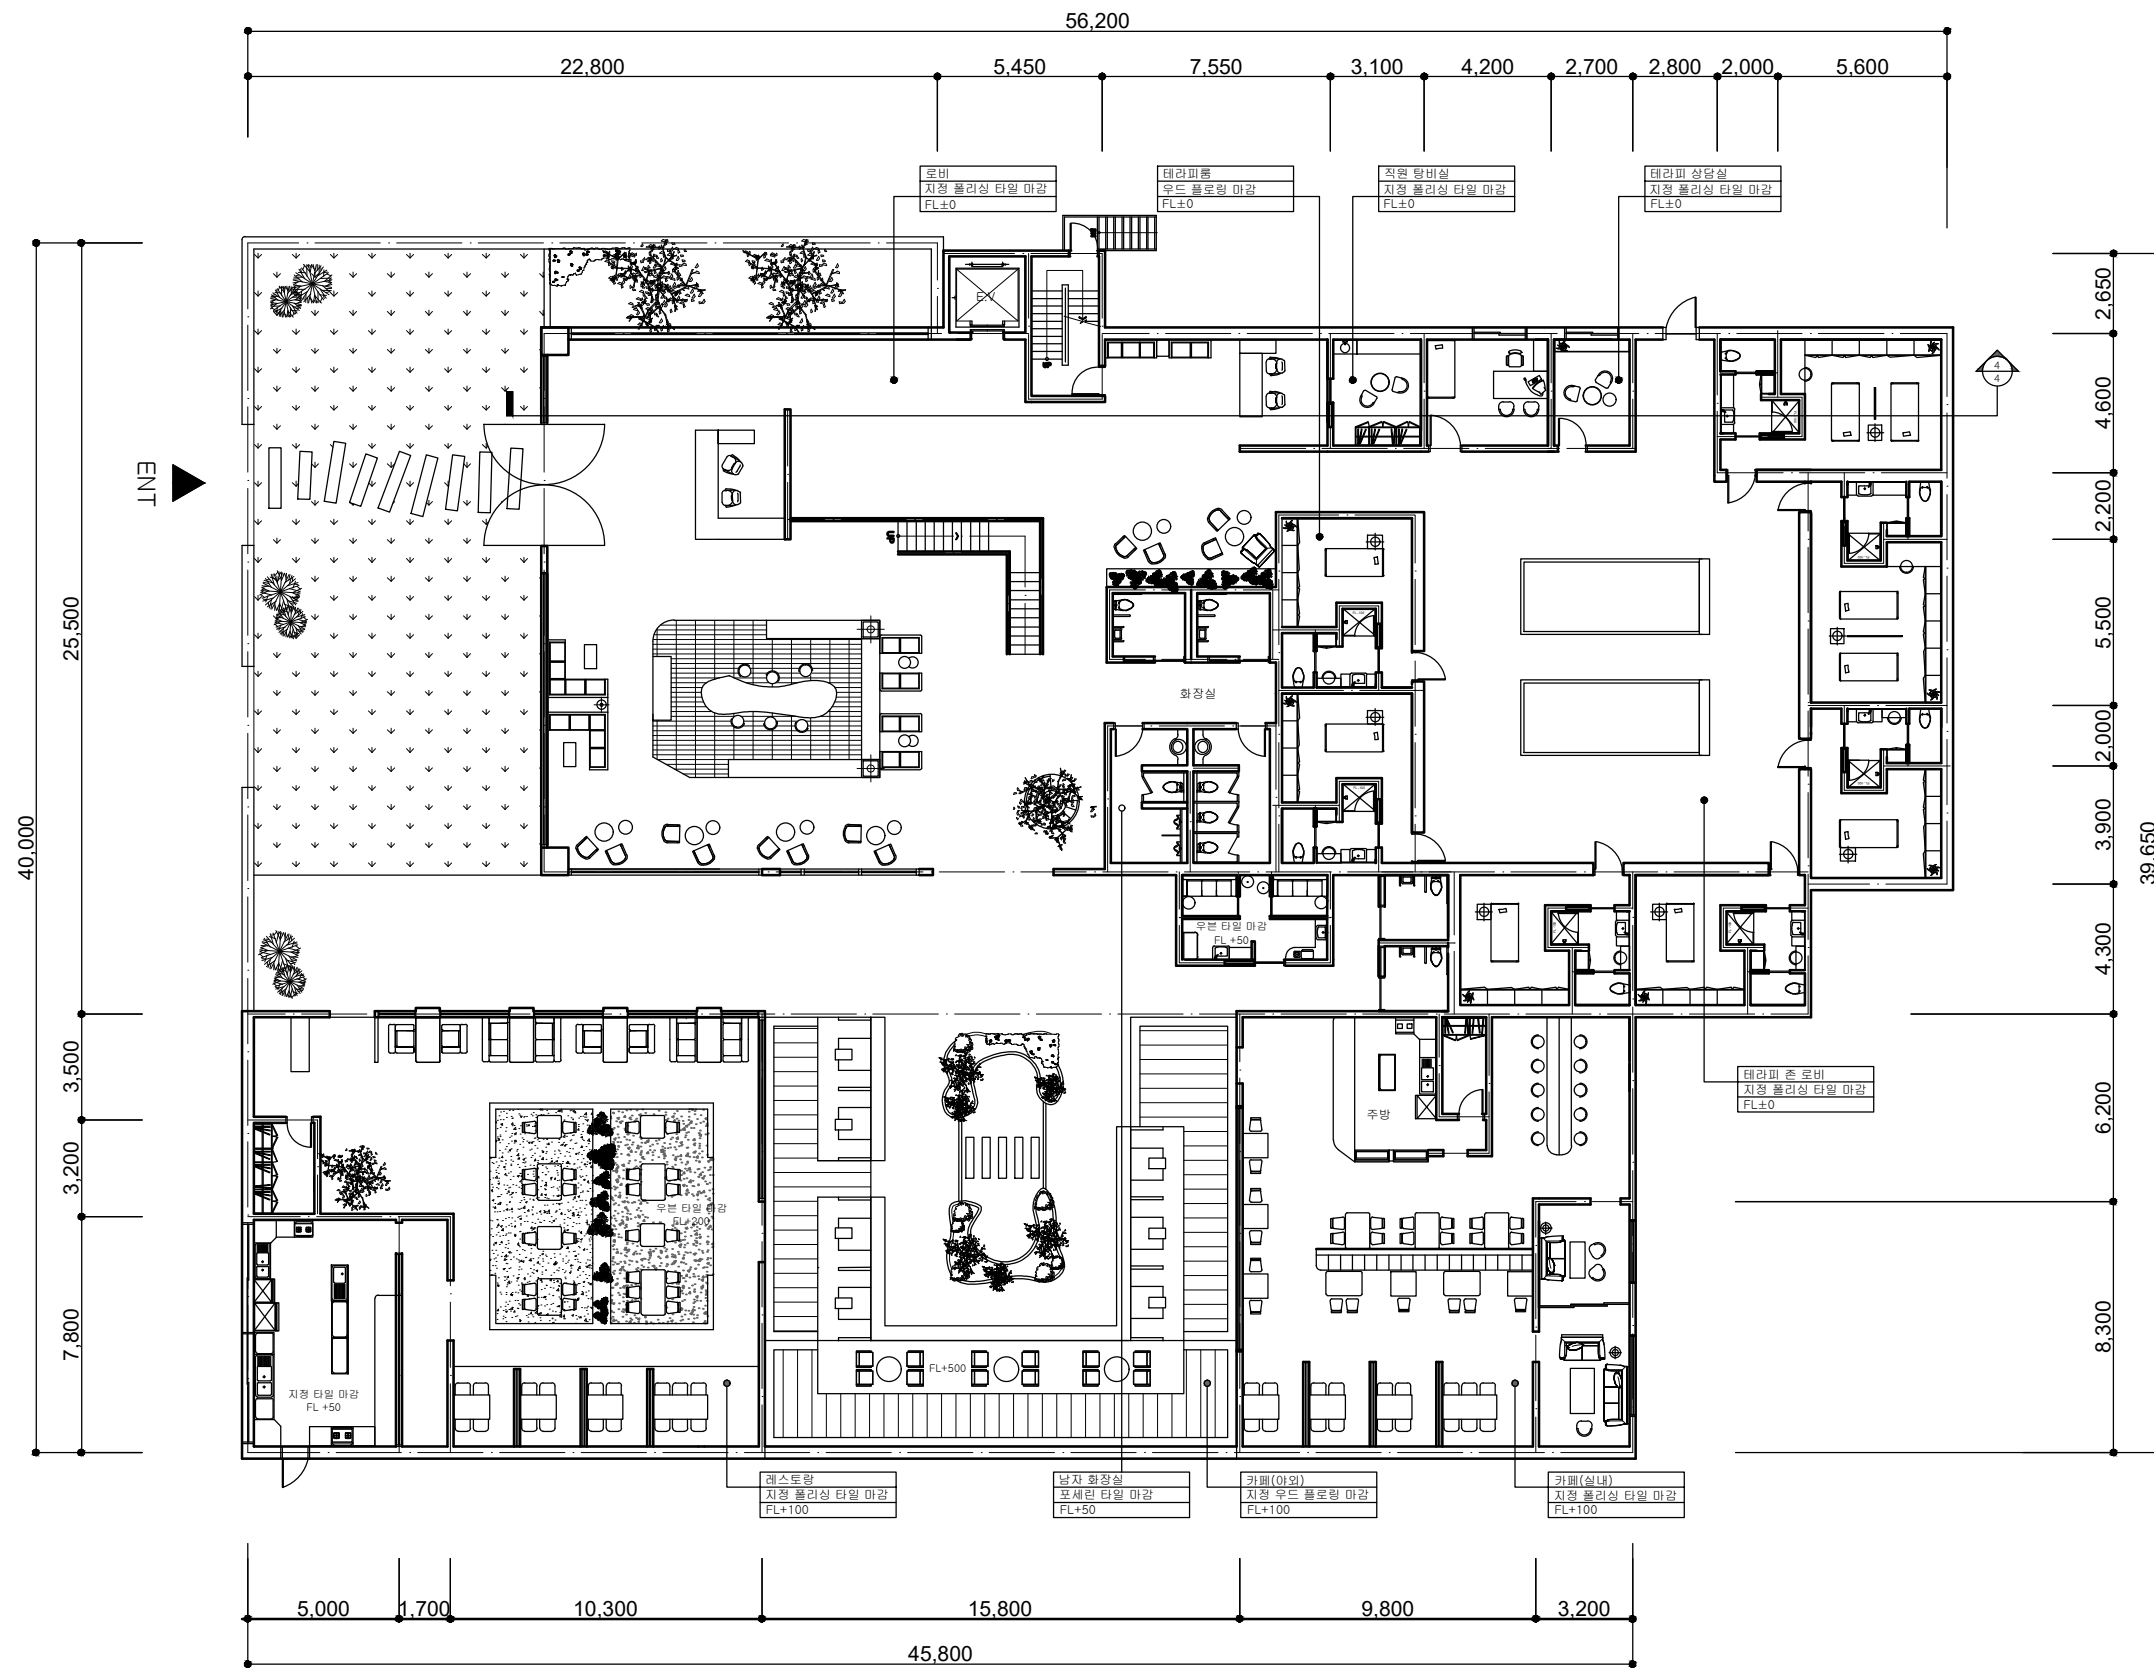

UP-DATE

NO.	DESCRIPTION	DATE
REVISIONS		

DRAWING BY

CHECKED BY


NAME OF COMPANY

DRAWING NO.

SCALE

A1 : A3 : 1/250

01

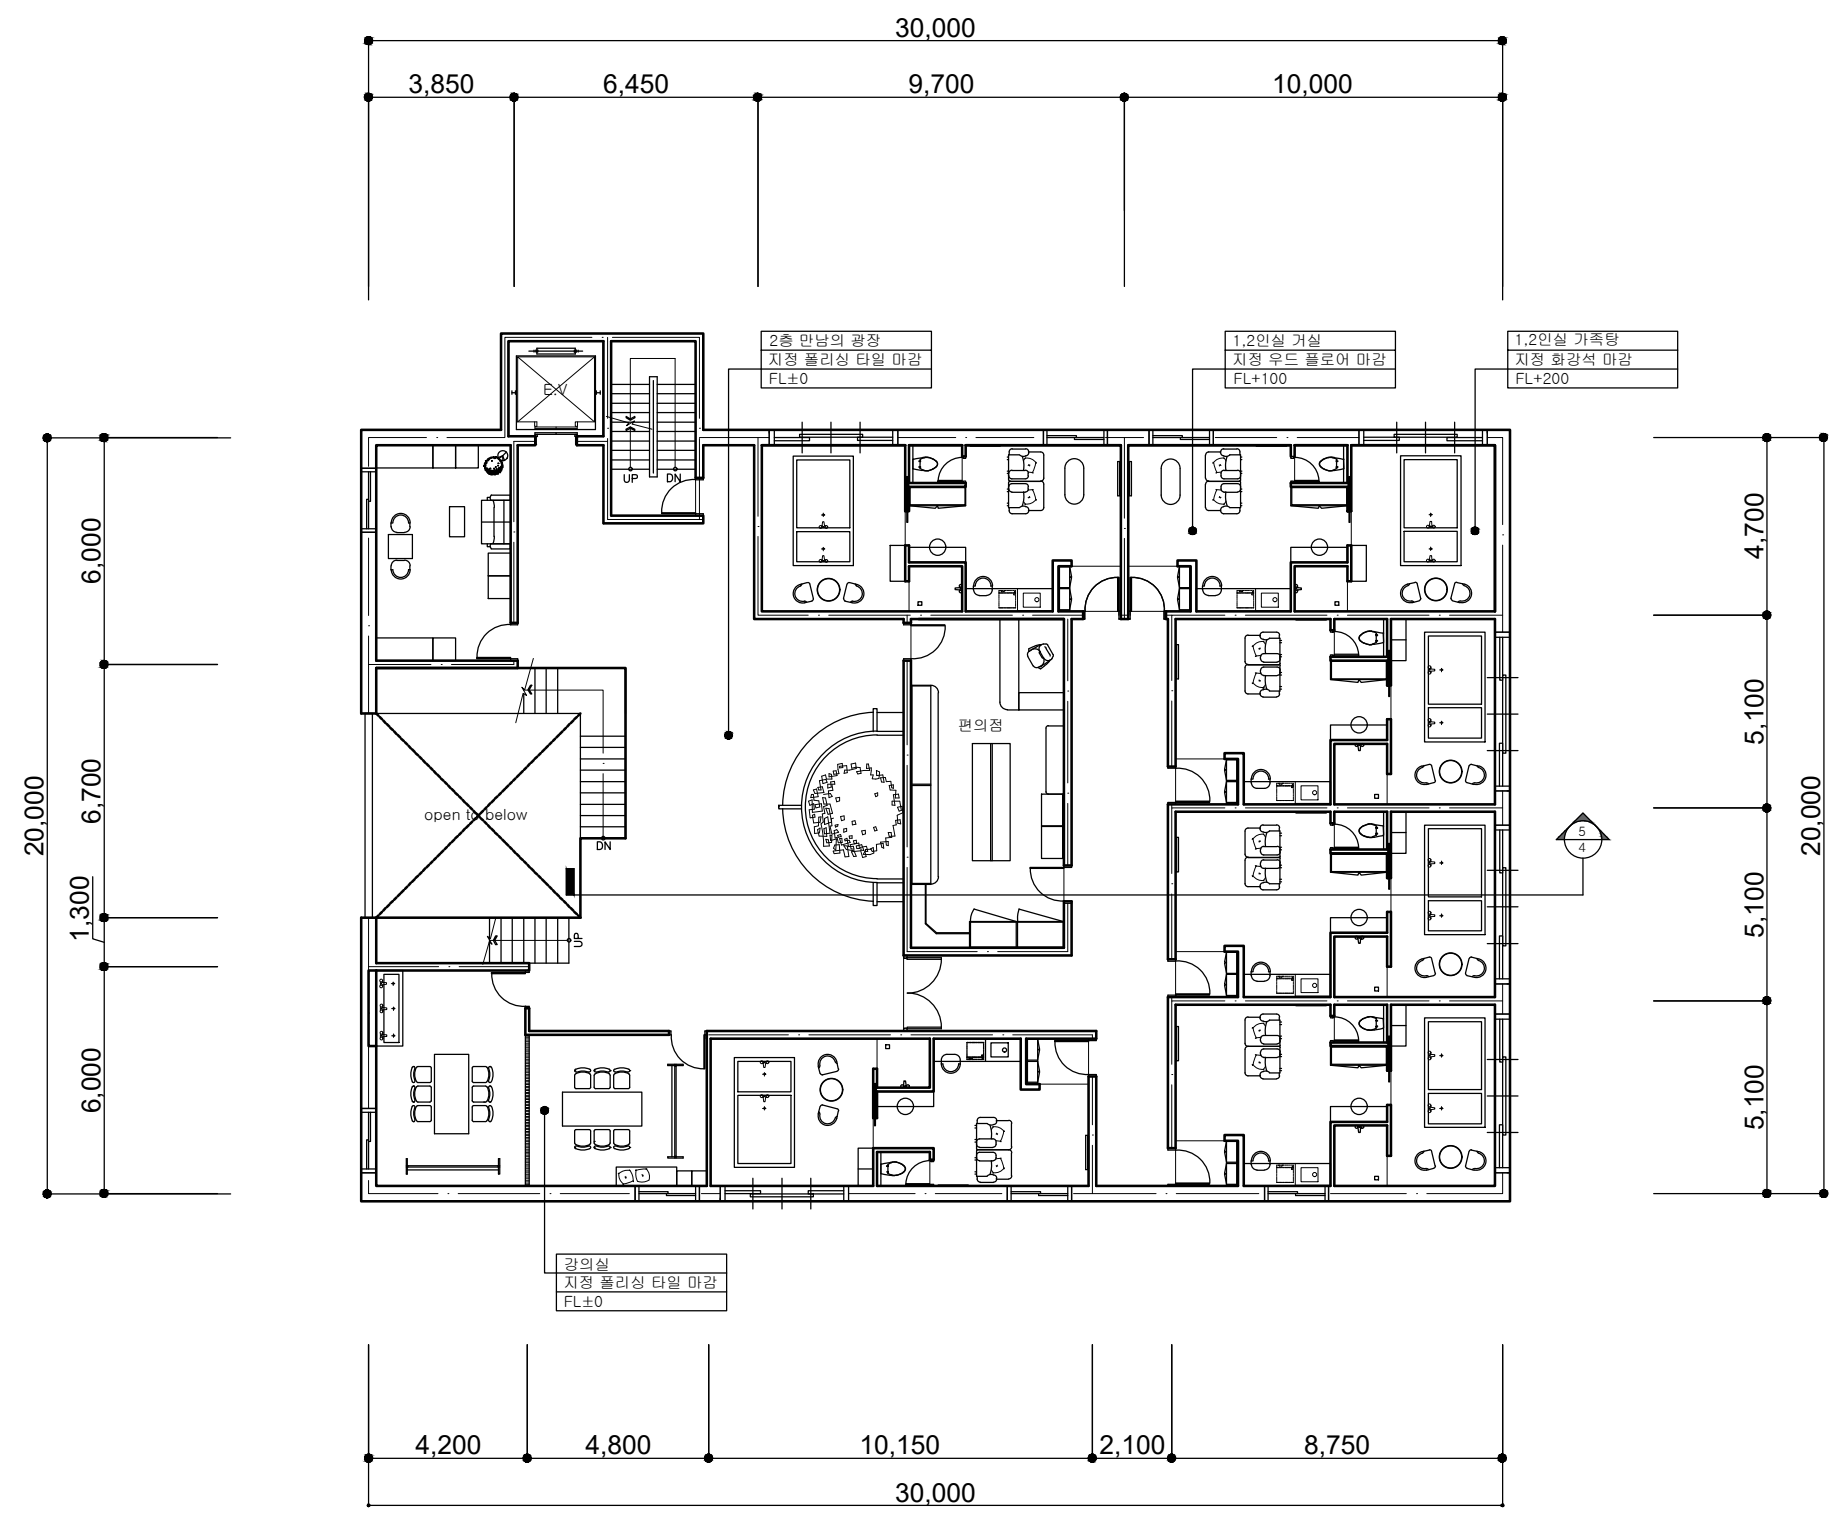

NO.	DESCRIPTION	DATE
REVISIONS		

DRAWING BY


CHECKED BY

NAME OF COMPANY

DRAWING NO.

02

SCALE
A1 : A3 : 1/200

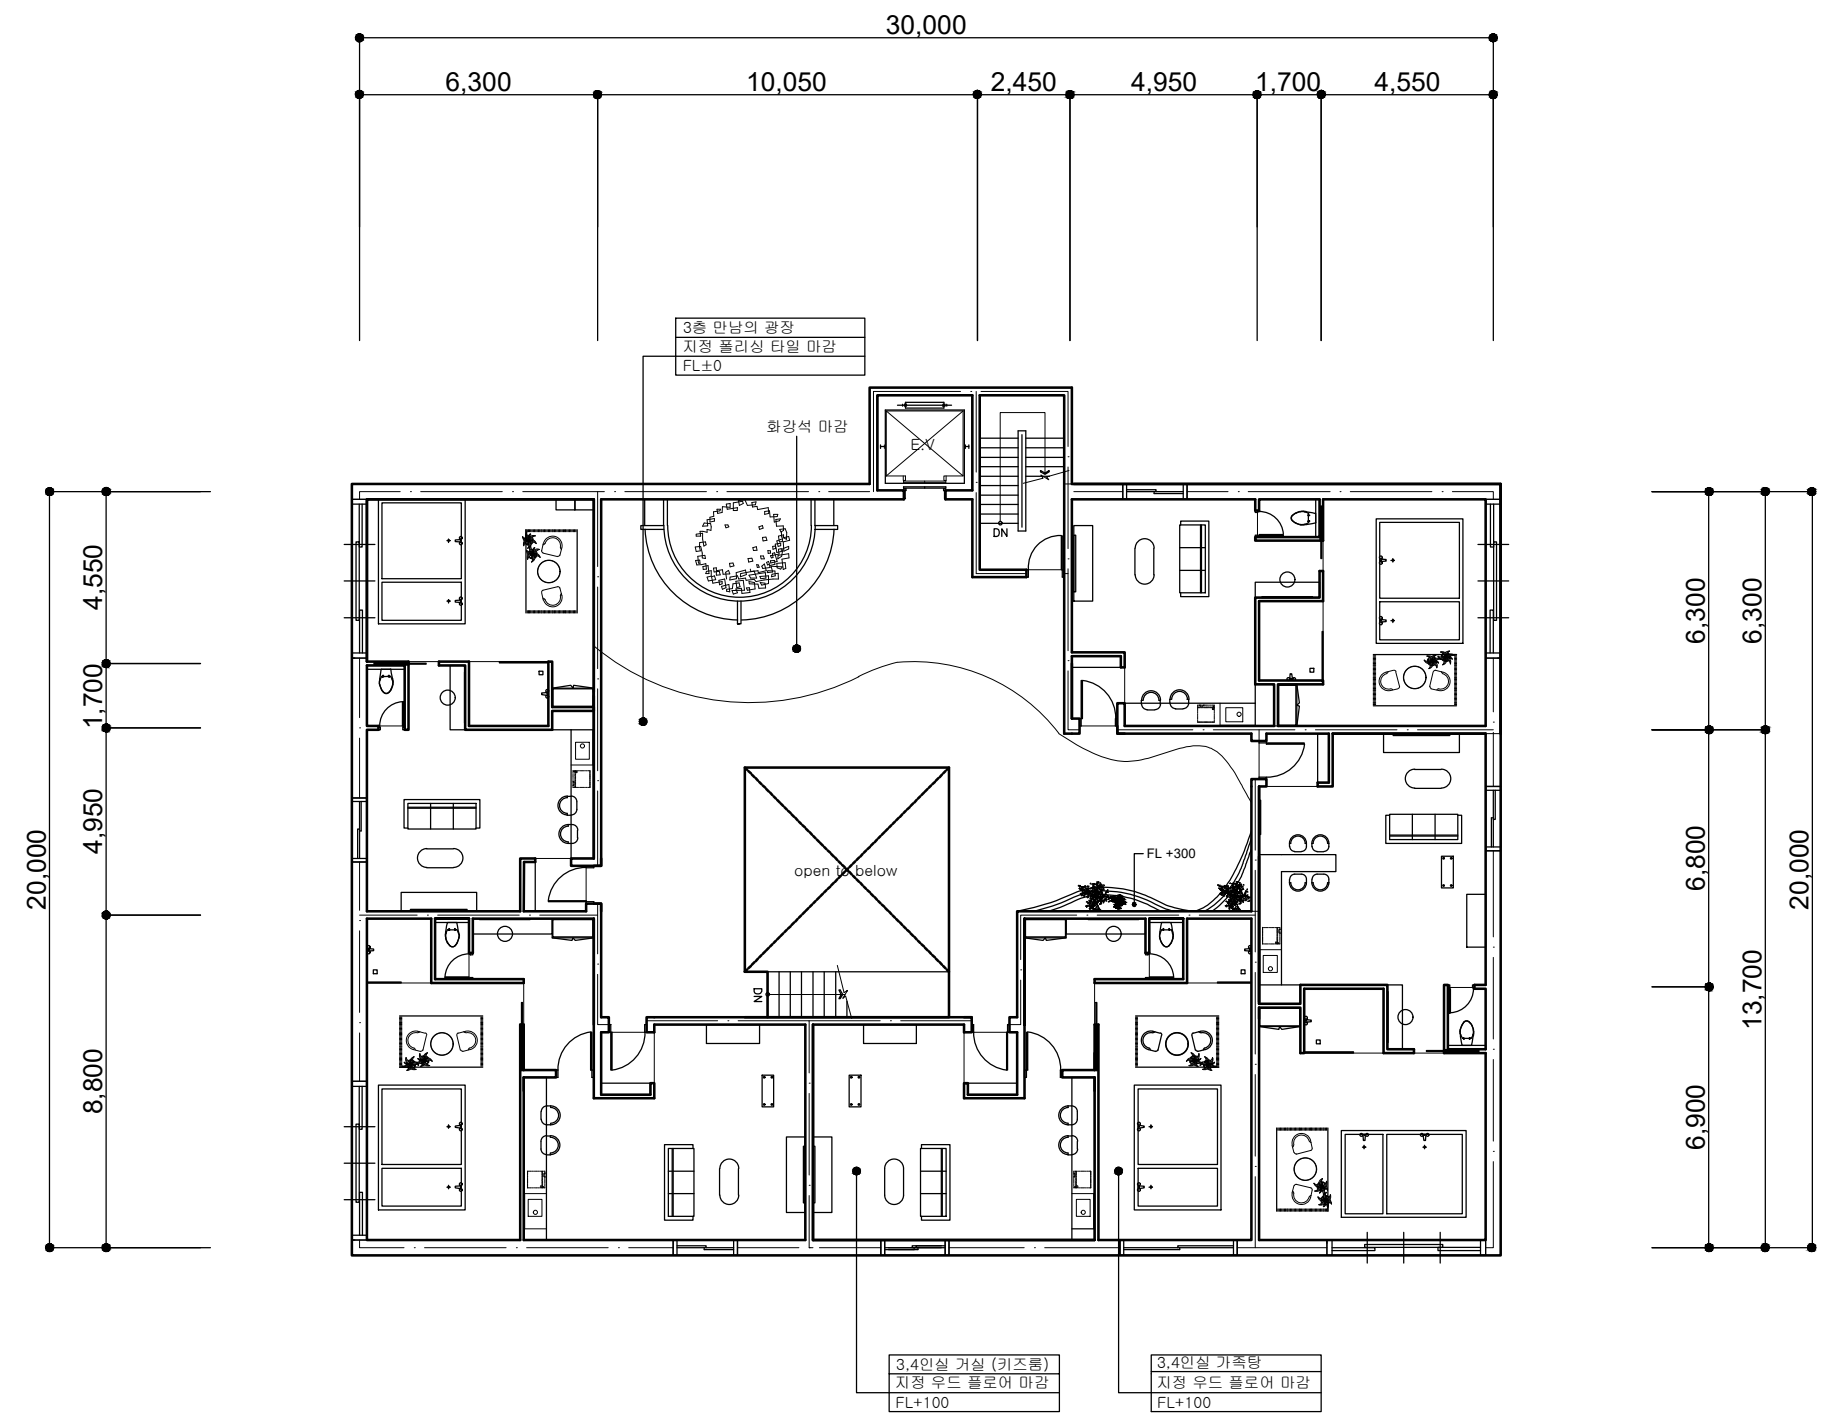

UP-DATE		
NO.	DESCRIPTION	DATE
REVISIONS		


DRAWING BY

CHECKED BY

NAME OF COMPANY

DRAWING NO.


03

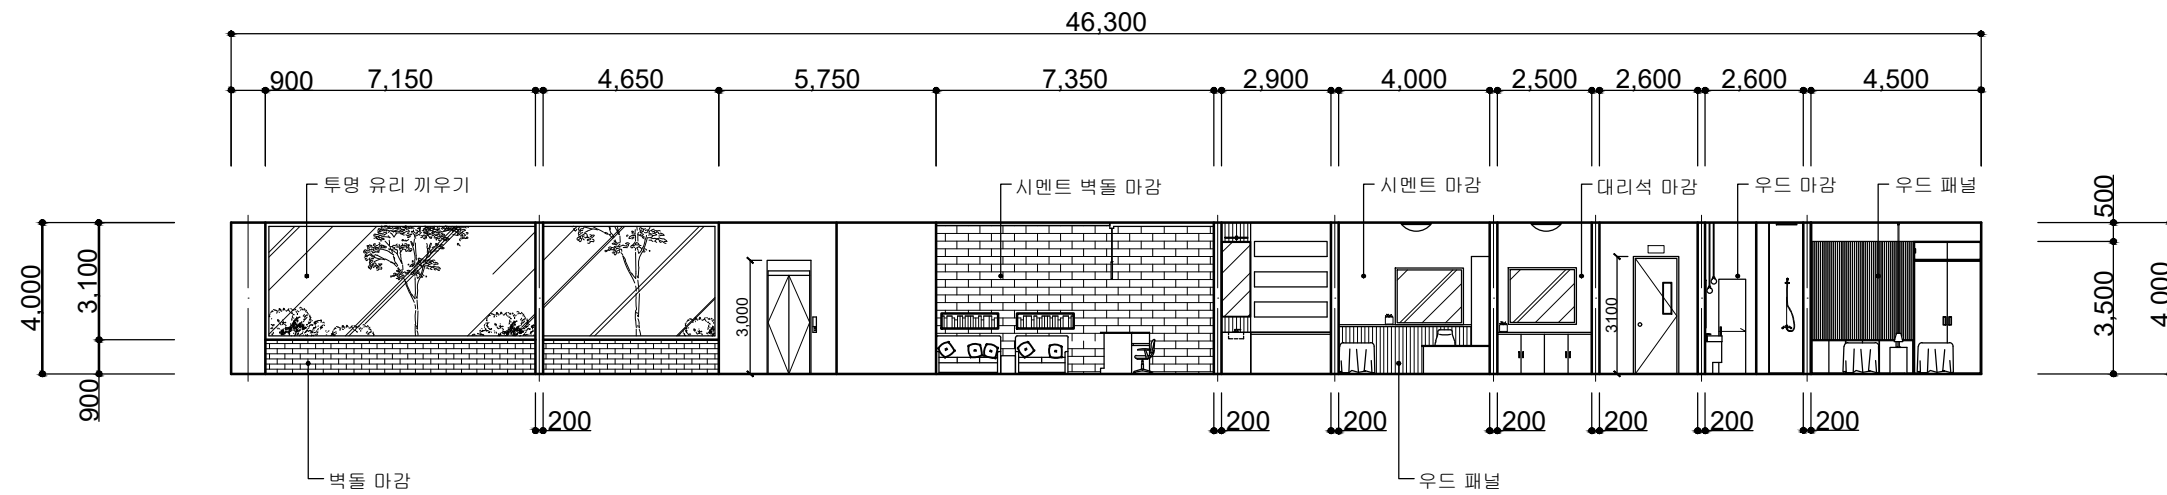

04 1st ELEVATION - A

SCALE

A1 : A3 : 1/200

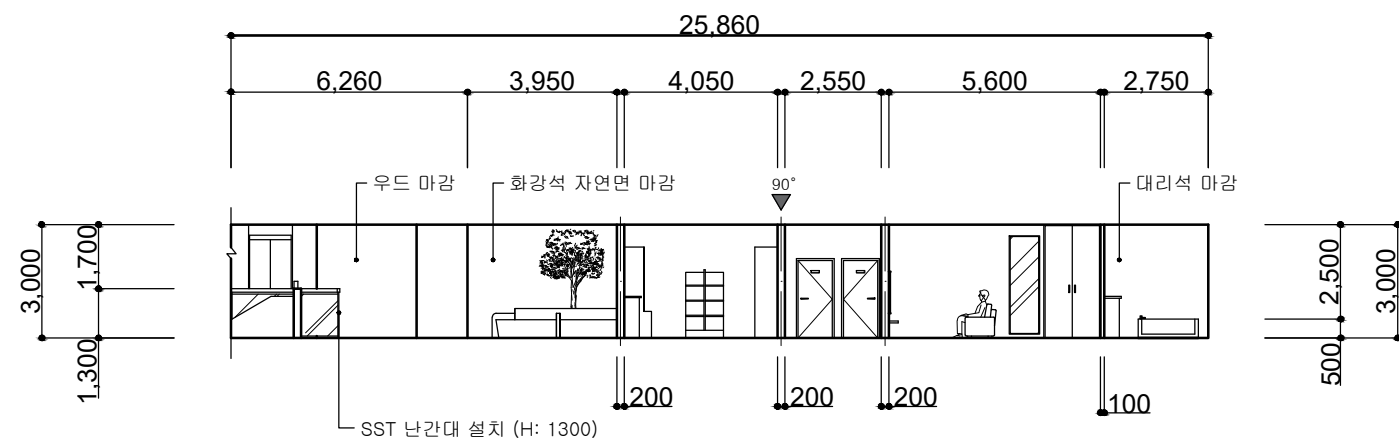

05 2nd ELEVATION - B

SCALE

A1 : A3 : 1/200

UP-DATE

NO.	DESCRIPTION	DATE
-----	-------------	------

REVISIONS		
-----------	--	--

DRAWING BY


CHECKED BY

NAME OF COMPANY

DRAWING NO.

04,05

LIGHTING	
SYMBOL	DESCRIPTION
⬇	DOWN LIGHT
••••	RAIL LIGHT
	한치 구름 조명
+++++	PENDANT
	천정등 (800 X 800)
	천정등 (R400)
	천정등 (260 X 260)
••	EDISON PENDANT LIGHT
	SPHERE PENDANT LIGHT
	HALOGEN
	RATTAN PENDANT LIGHT

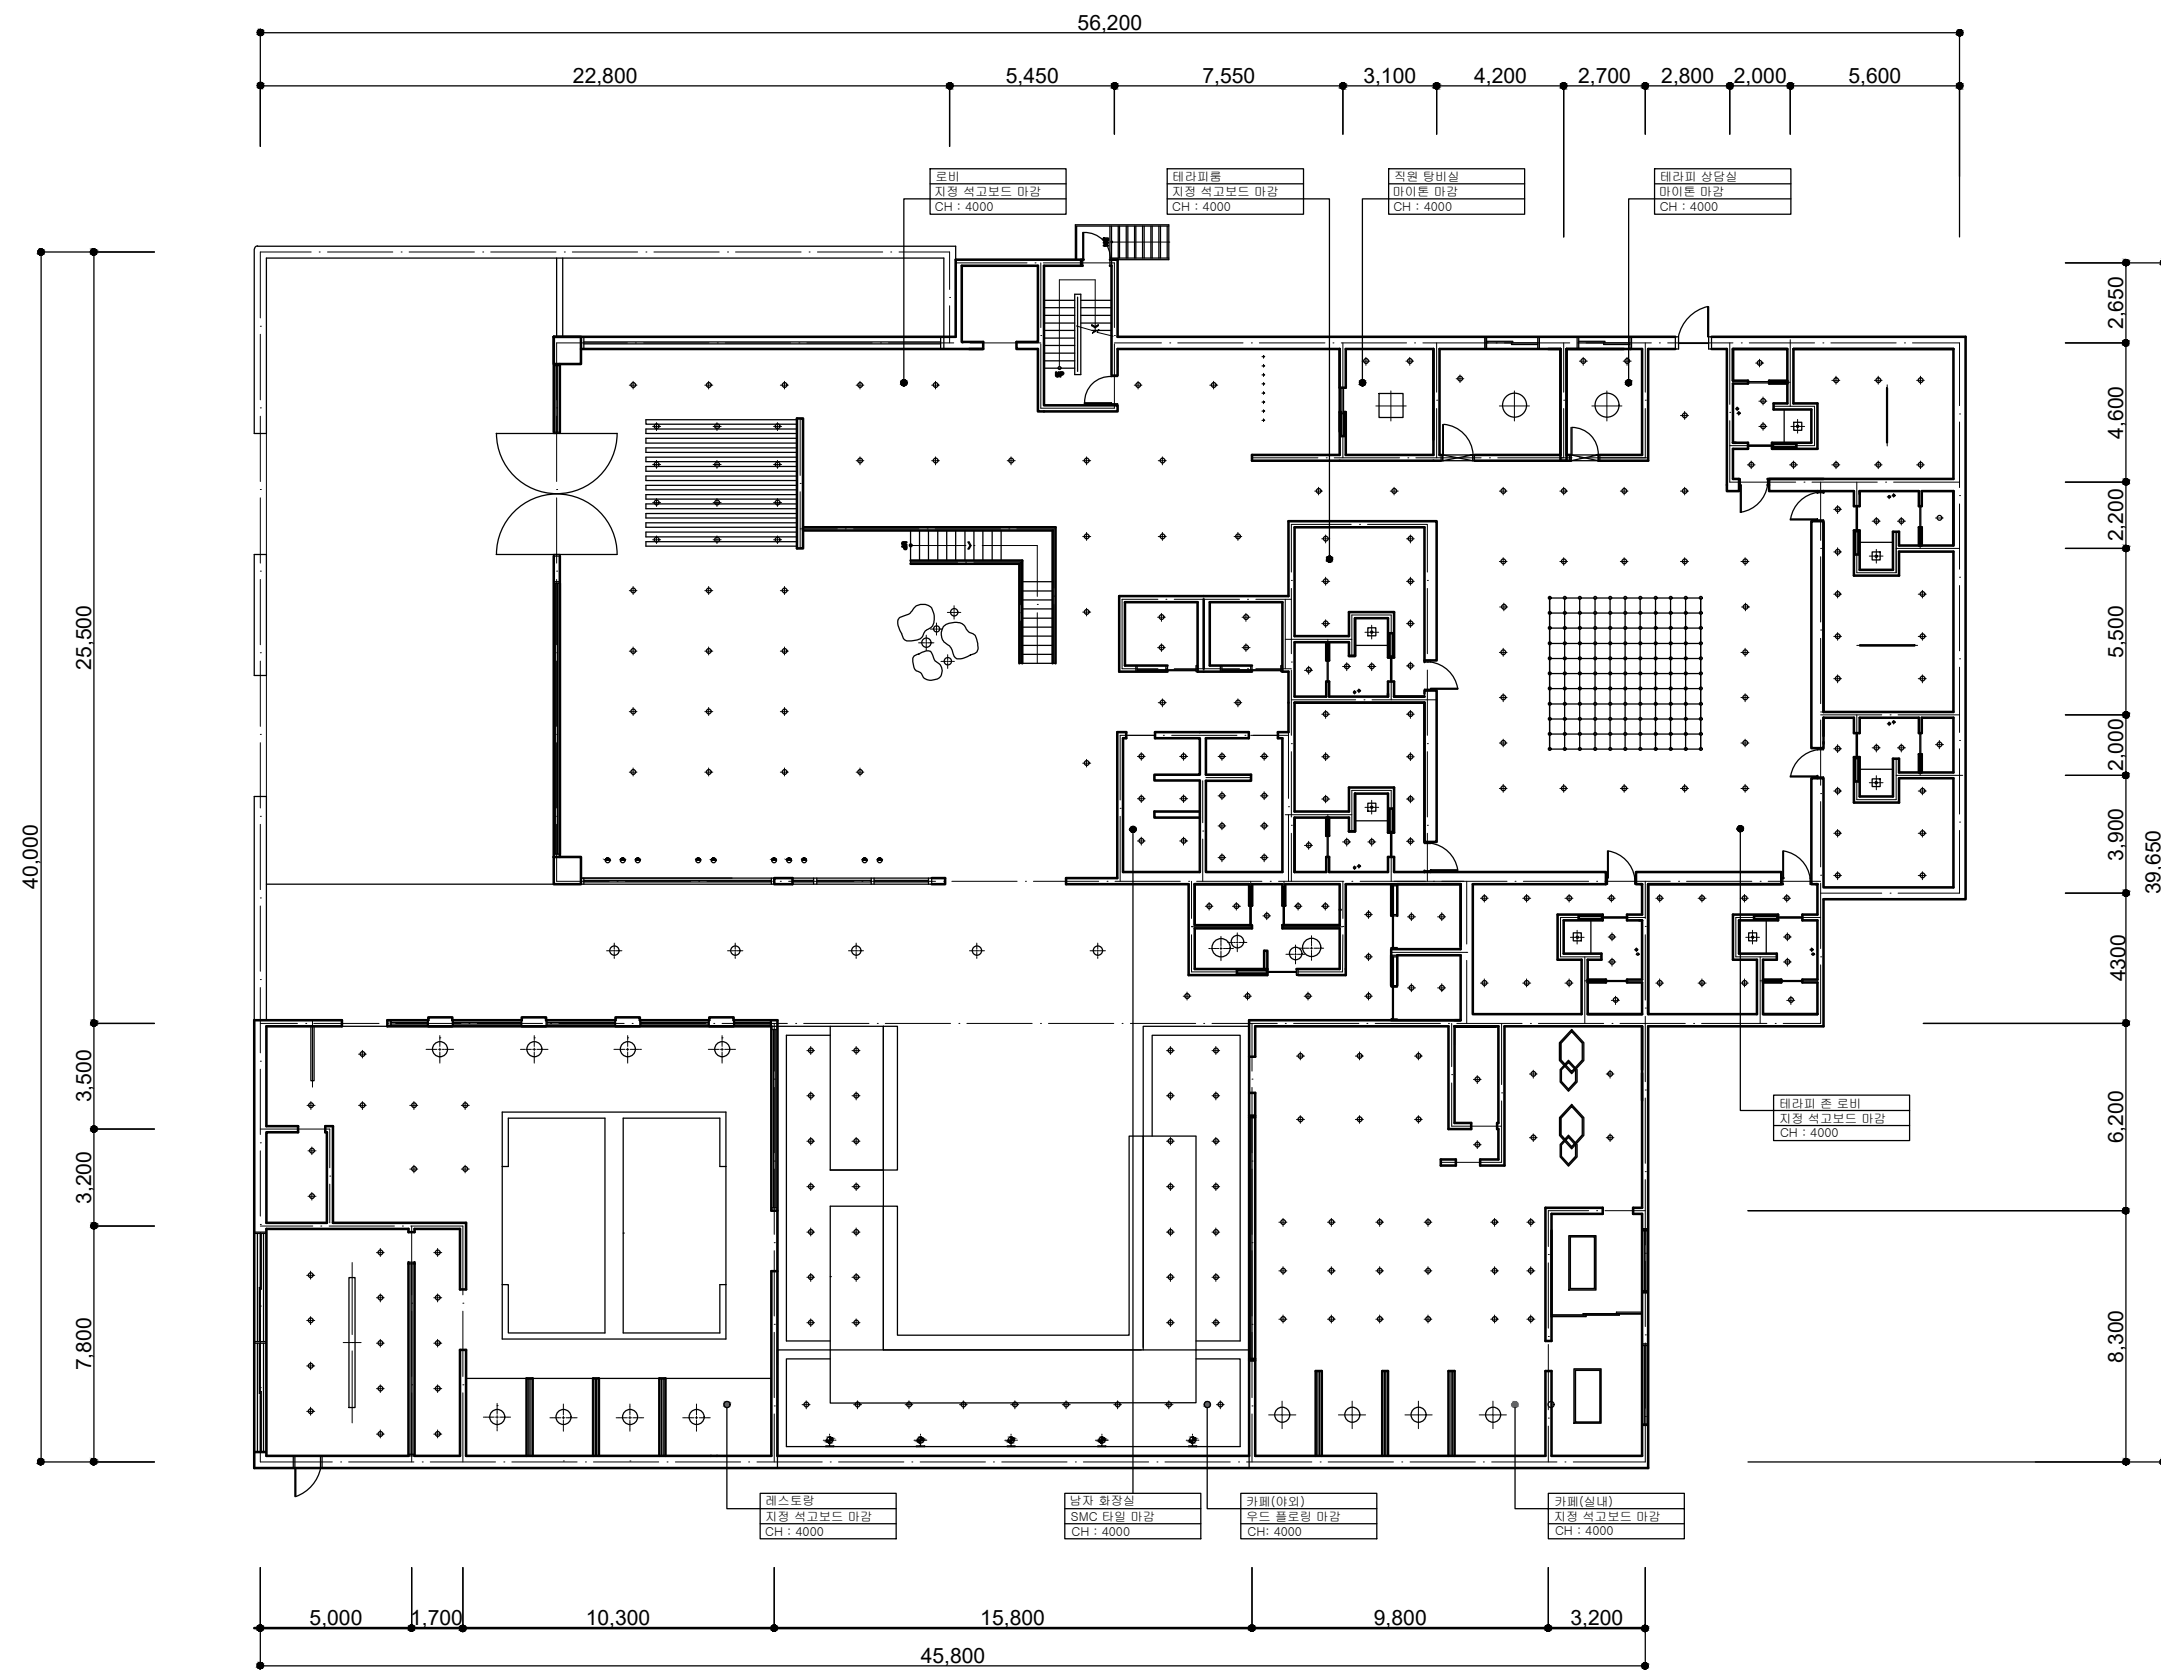

NO.	DESCRIPTION	DATE
REVISIONS		

DRAWING BY

CHECKED BY

NAME OF COMPANY

DRAWING NO.


06

SCALE

A1 : A3 : 1/250

LIGHTING

SYMBOL	DESCRIPTION
⊕	DOWN LIGHT
⊞	천정등 (500 X 500)
⊞	천정등 (1000 X 150)
⊞	천정등 (1500 X 1300)
⊞	천정등 (1500 X 225)
◆	PENDANT LIGHT

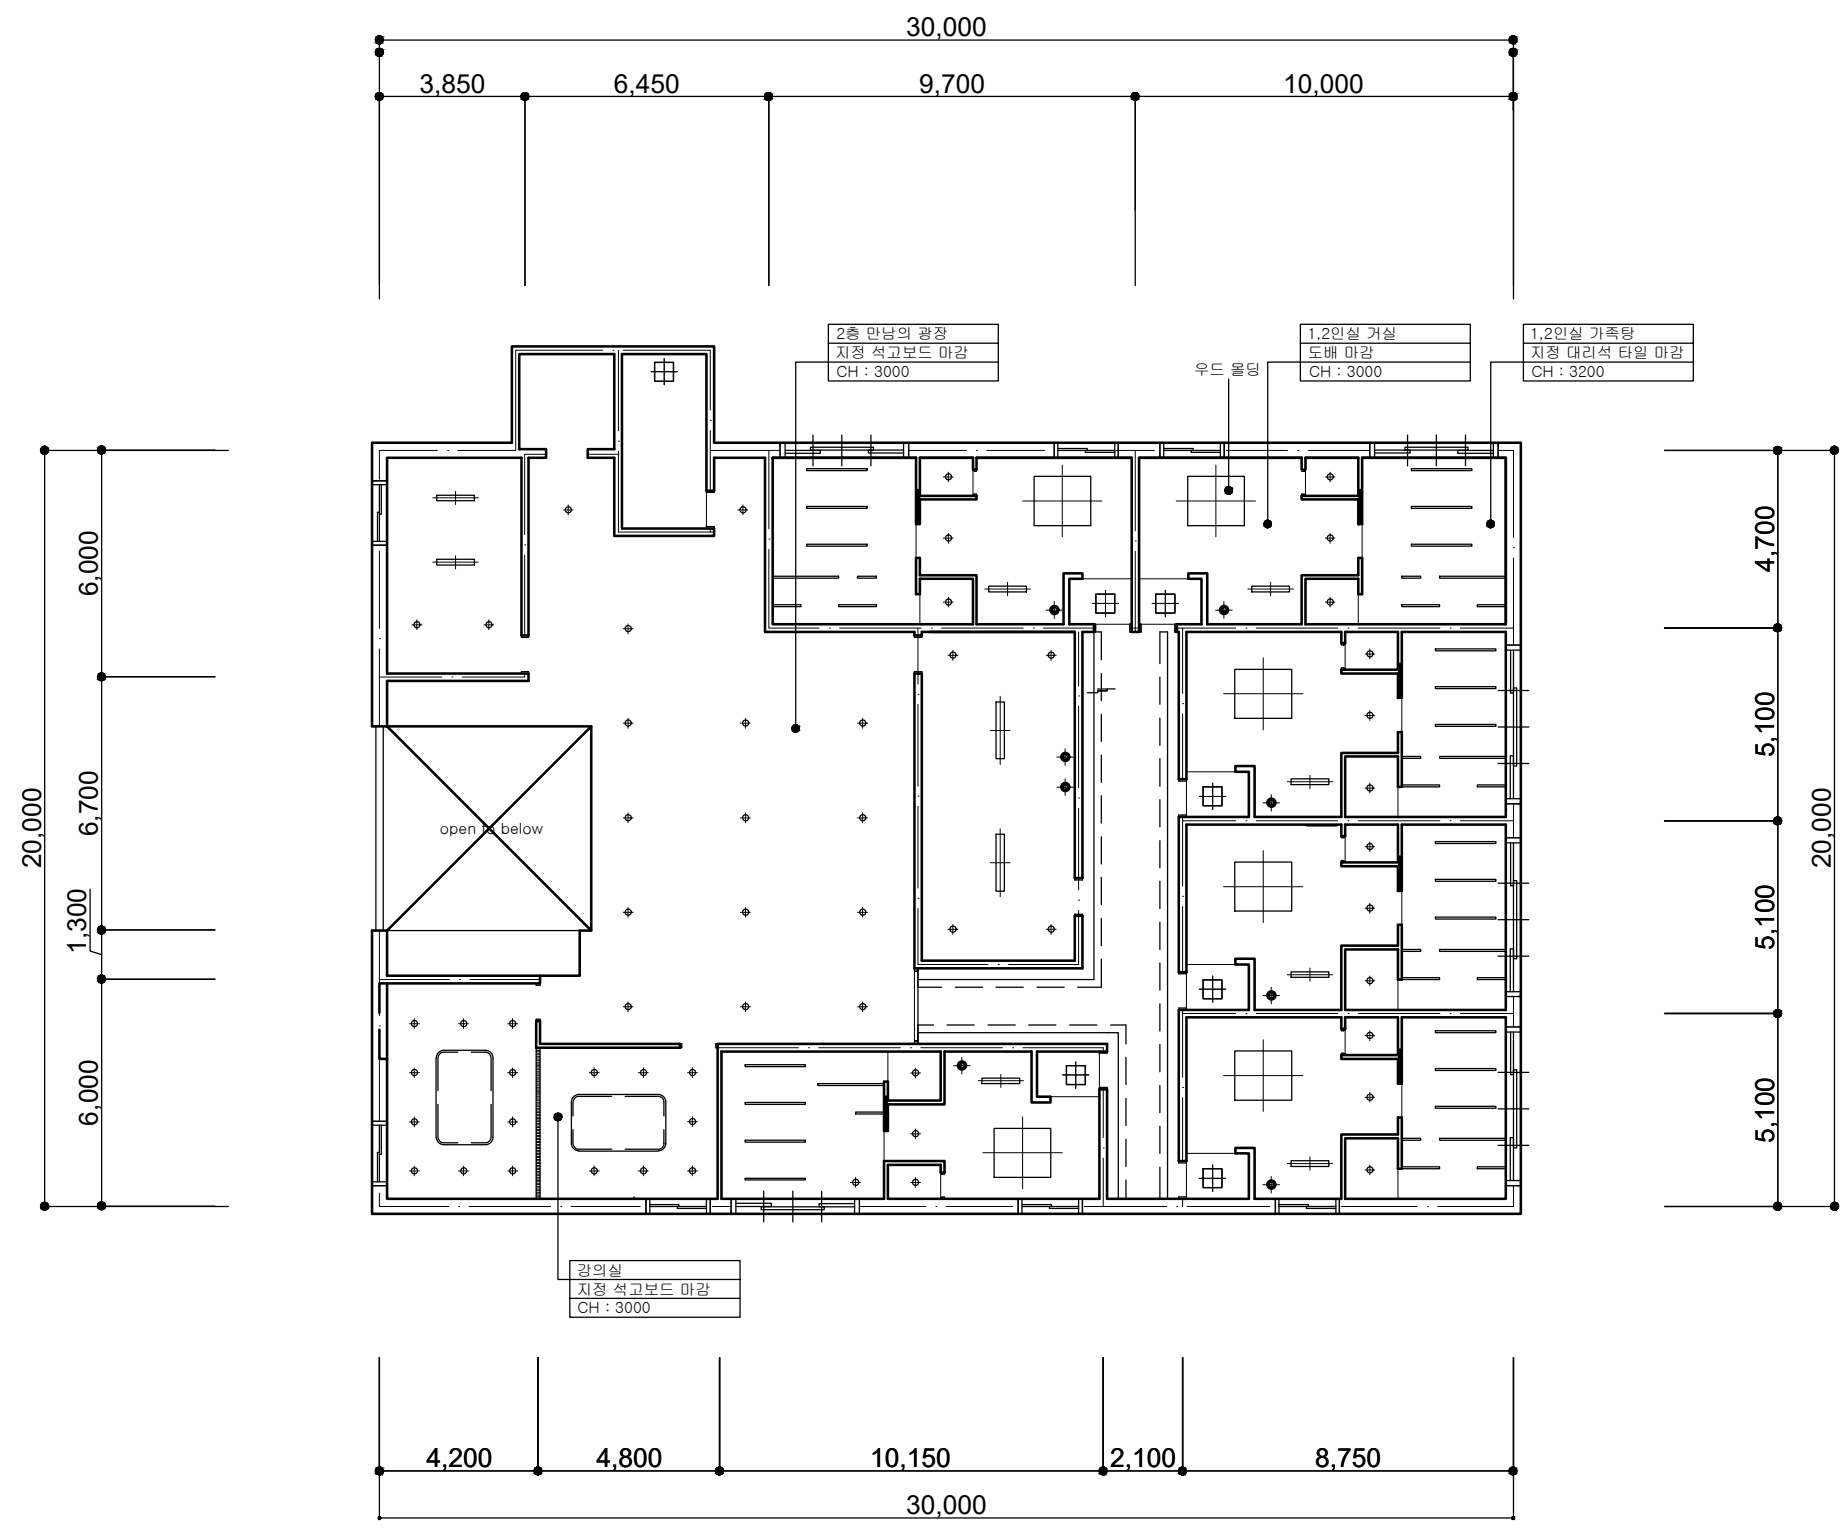

NO.	DESCRIPTION	DATE
REVISIONS		

DRAWING BY


CHECKED BY

NAME OF COMPANY

DRAWING NO.

07

LIGHTING	
SYMBOL	DESCRIPTION
⊕	DOWN LIGHT
⊞	천정등 (500 X 500)
⊞	천정등 (1000 X 150)
⊞	천정등 (2300 X 2100)
⊙	PENDANT LIGHT

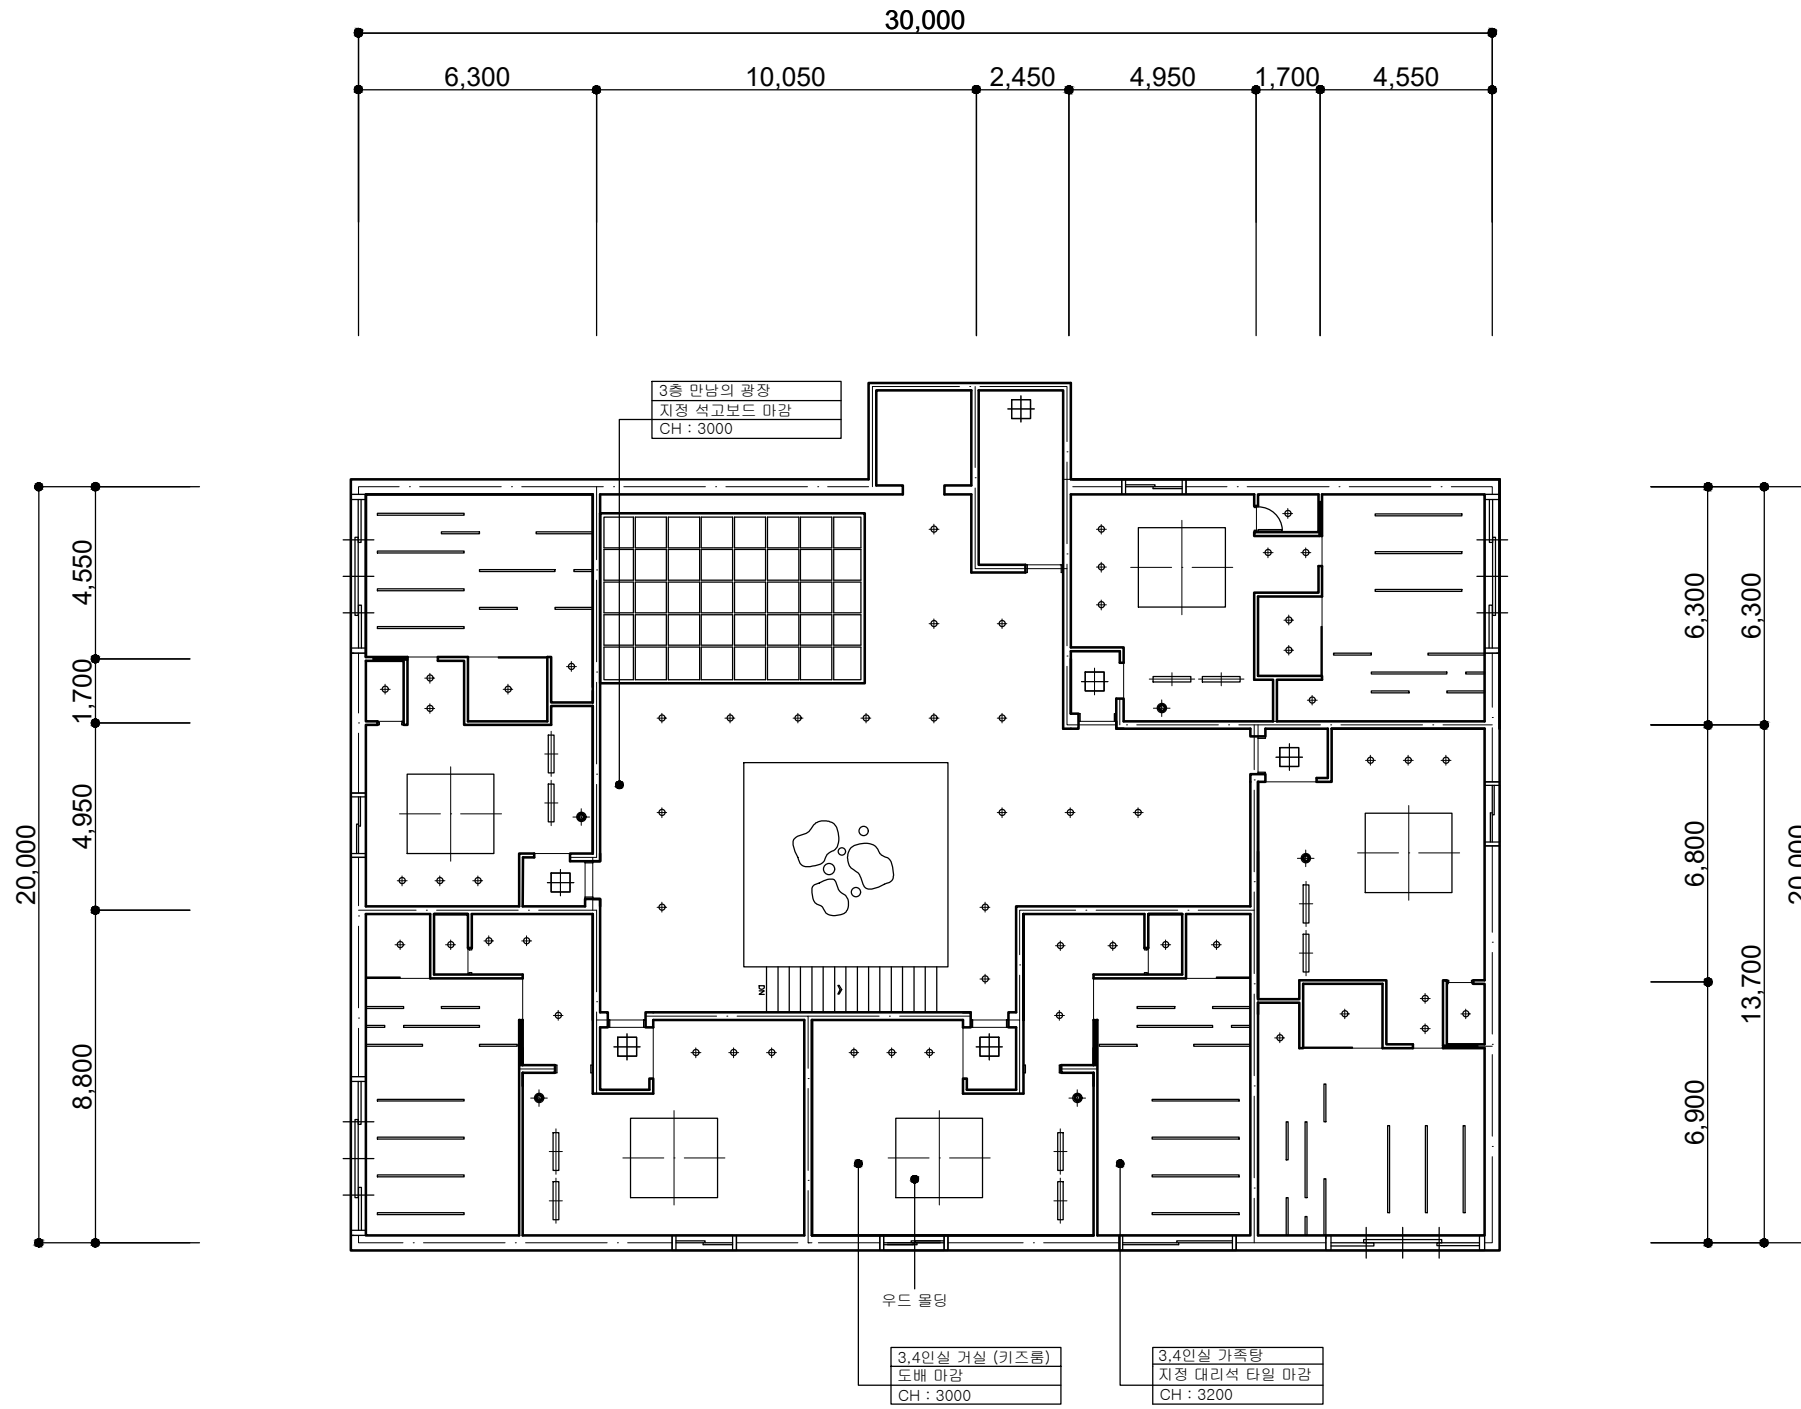

NO.	DESCRIPTION	DATE
REVISIONS		

DRAWING BY

CHECKED BY

NAME OF COMPANY

DRAWING NO.

08

SCALE

A1 : A3 : 1/200

LIGHTS

SCALE A3 : 1/150

LIGHTING			
SYMBOL	DESCRIPTION	개수	도면 번호
	DOWN LIGHT	269	05
	DOWN LIGHT 2	5	05
	RAIL LIGHT	4	05
	한지 그룹 조명	1	05
	PENDANT LIGHT	1	05
	천정등 (800 X 800)	1	05
	천정등 (R400)	2	05
	천정등 (260 X 260)	7	05
	천정등 (R210, R300)	2	05
	EDISON PENDANT LIGHT	7	05
	SPHERE PENDANT LIGHT	8	05
	HALOGEN	5	05
	RATTAN PENDANT LIGHT	4	05

LIGHTING			
SYMBOL	DESCRIPTION	개수	도면 번호
	DOWN LIGHT	57	06
	천정등 (500 X 500)	7	06
	천정등 (1000 X 150)	8	06
	천정등 (1500 X 1300)	6	06
	천정등 (1500 X 225)	2	06
	PENDANT LIGHT	6	06
LIGHTING			
SYMBOL	DESCRIPTION	개수	도면 번호
	DOWN LIGHT	56	07
	천정등 (500 X 500)	6	07
	천정등 (1000 X 150)	10	07
	천정등 (2300 X 2100)	5	07
	PENDANT LIGHT	5	07

SYMBOL	DESCRIPTION	개수	도면 번호
	HALOGEN X 121	1	05
	HEXAGON PENDANT LIGHT	2	05
	RETANGULE PENDANT LIGHT	2	05
	PENDANT LIGHT (4300 X 200)	1	05
	PENDANT LIGHT (1800 X 100)	1	05